


DETAILS OF INCLUSIONS

- ⑩ Kitchens
- ⑪ Bedroom wardrobe
- ⑫ Hall cupboard
- ⑬ Vanity unit
- ⑭ Baths, shower screens and accessories
- ⑮ Stair handrails
- ⑯ Balcony handrails
- ⑰ Loft stair, cupboard and handrail
- ⑱ Laundry and linen store
- ⑲ Storage units
- ⑳ Drying room racks
- ㉑ Drying room seat
- ㉒ Ski room racks
- ㉓ Ski room tuning bench
- ㉔ Loft wardrobe
- ㉕ Loft screens
- ㉖ Front door and glazing detail
- ㉗ Lighting and power layout
- ㉘ Door hardware

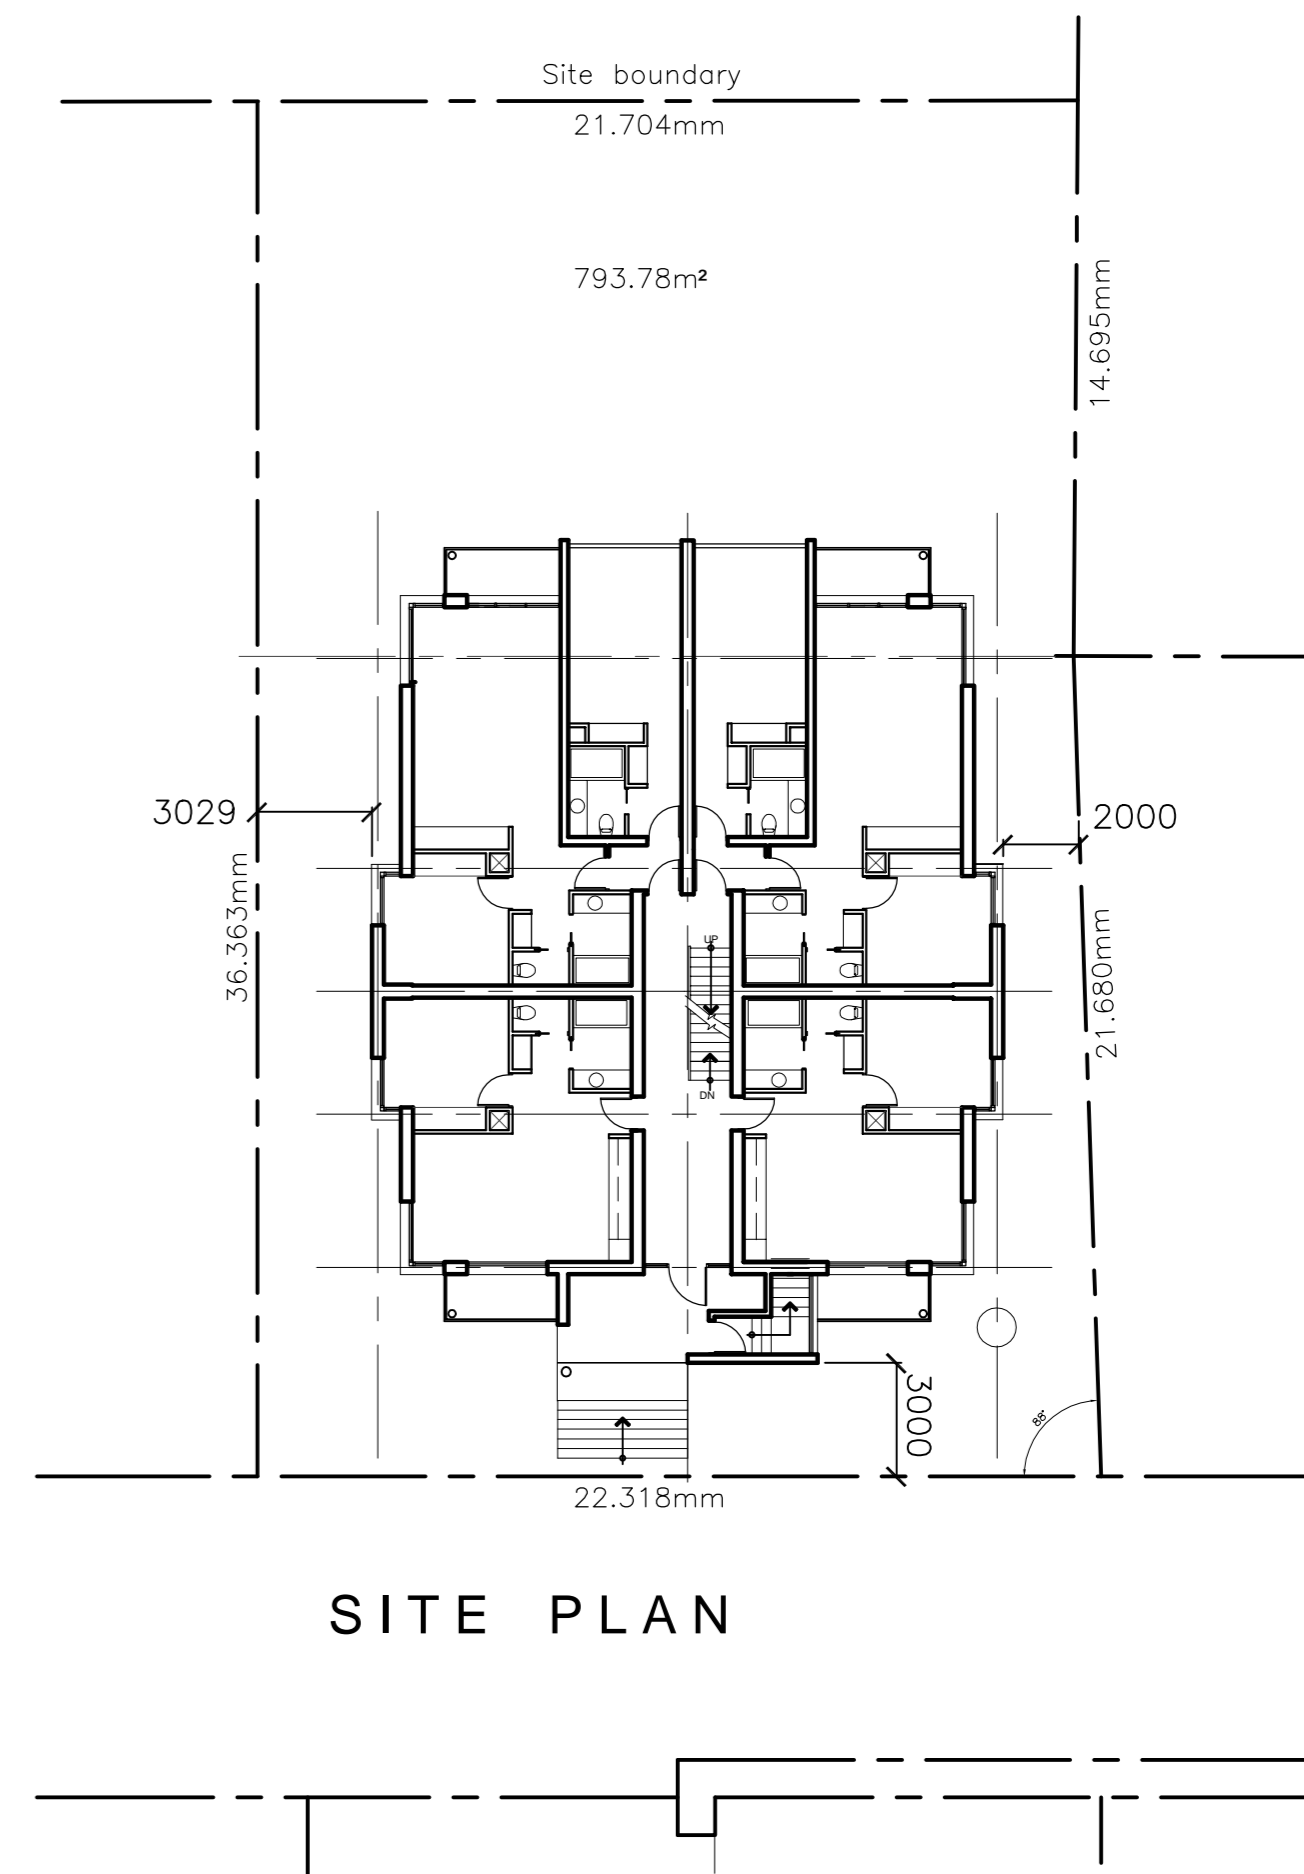

PRELIMINARY

<p>SOUTH</p>	Date	Issue	Date	Issue

PROJECT	DEEP TRACKS APARTMENTS - HIRAFU BLOCK F
DRAWING	PLANS

F O S K E T T ARCHITECTS	Confirm all dimensions and levels on site before commencing work or preparing shop drawings	Scale: 1:100 1:200 Date: 3.8.04 Job No: 0343 Drawn: BF/FR Checked: BF	DRAWING NO. SP1 ISSUE A
	OFFICE Address: Ground Floor AMP Building - 1 Hobart Place CIVIC ACT 2601 POSTAL Address: 1 Booroodara Street REID ACT 2612	PHONE (02) 6257 1123 FAX (02) 6257 1314	